



Architecture / Planning / Interior Design
Portland Seattle Los Angeles Washington DC New York
925 Fourth Ave., Suite 2400
Seattle, Washington 98104
PH: 206 623 9414
FAX: 206 623 7868

Consultants

STRUCTURAL ENGINEER
ARUP
901 MARKET STREET, SUITE 260
SAN FRANCISCO, CA 94103

MECHANICAL ENGINEER
SYSKA HENNESSY GROUP
1500 W OLYMPIC BLVD, SUITE 680
LOS ANGELES, CA 90064

ELECTRICAL ENGINEER
SYSKA HENNESSY GROUP
1500 W OLYMPIC BLVD, SUITE 680
LOS ANGELES, CA 90064

CIVIL ENGINEER
COUGHLIN PORTER LUNDEN
413 PINE STREET, SUITE 300
SEATTLE, WA 98101

Revisions


5th + COLUMBIA TOWER

SEATTLE, WASHINGTON 98104

Drawing Title
FLOOR PLAN, LEVEL 05

Date: SEPTEMBER 19, 2007
Job No: S 21458.01
Drawn By: TEAM
Checked By: ZGF
Drawing No.

A2.16
OWNER REVIEW

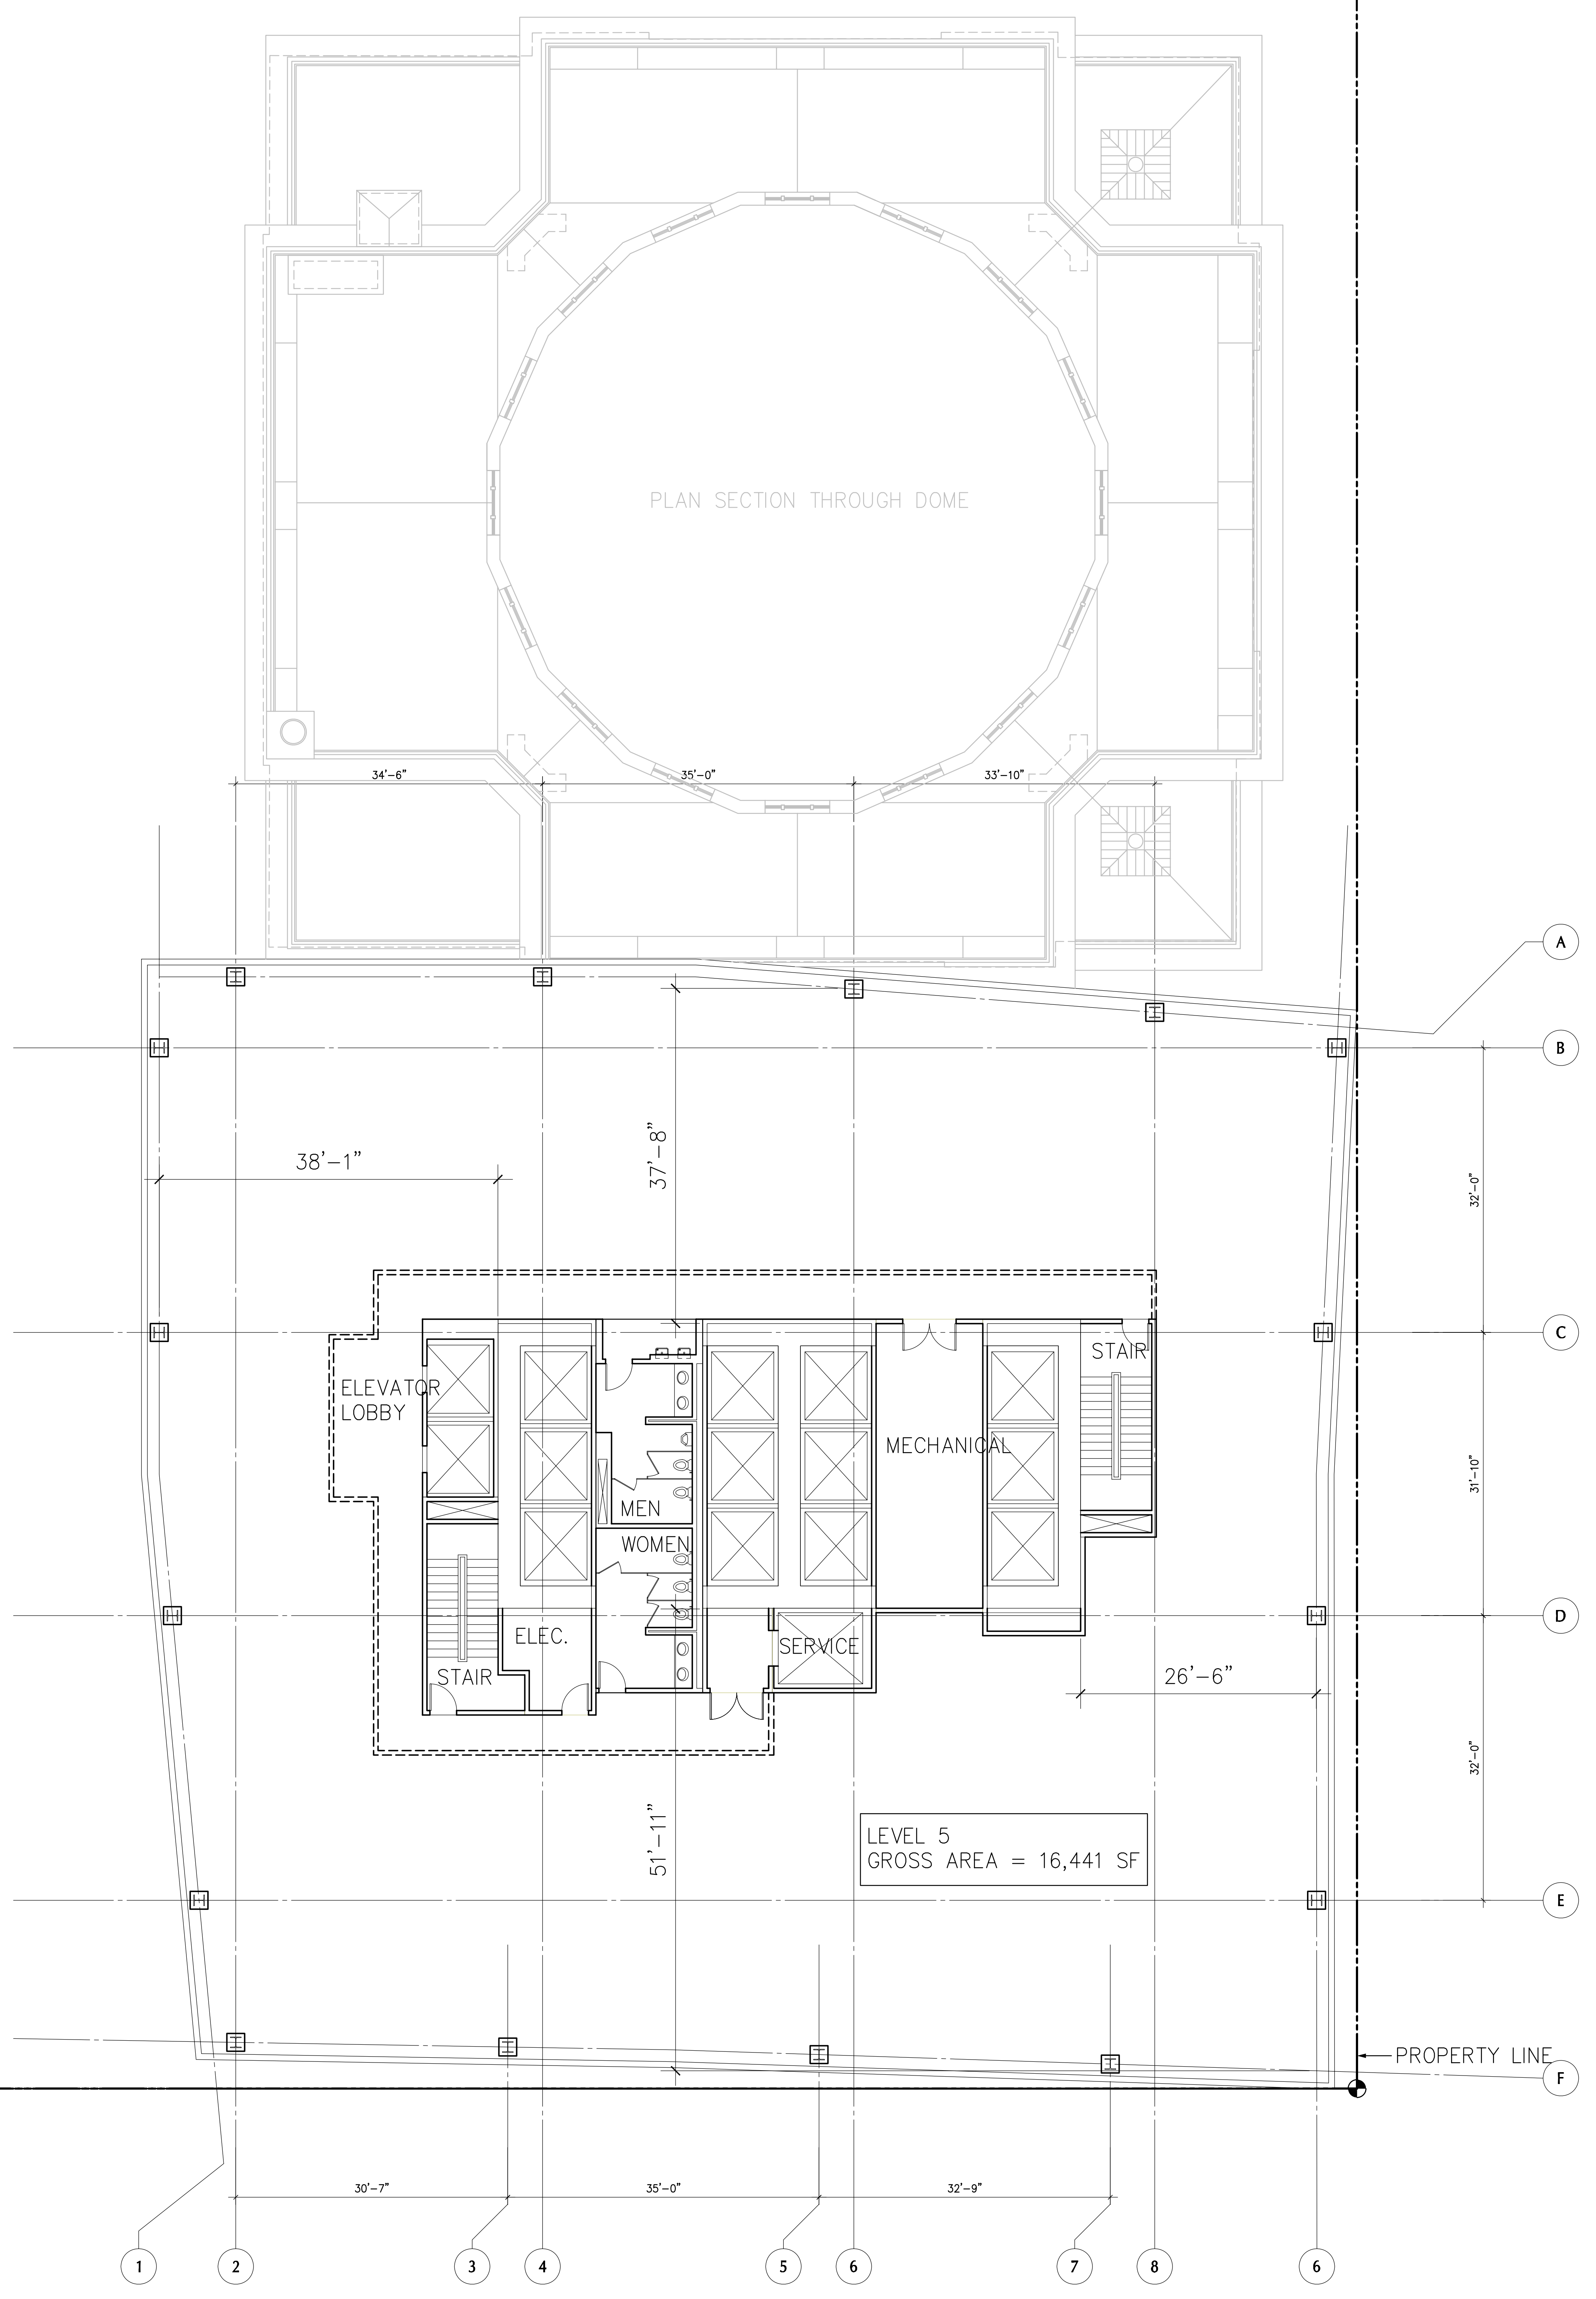

File: Z:\SEA\Projects\21458.01\5th\Sheets\A2-16.dwg
Plotted: 9/19/07 at 11:02am By: sgr
PLOT: zfp-5th.dwg in: c:\p1\cadd\p1-05.dwg

1 FLOOR PLAN, LEVEL 05
A2.16 SCALE: 1/16" = 1'-0" 